


4WAYS SPN DISTRIBUTION BOARD SECURITY HOUSE

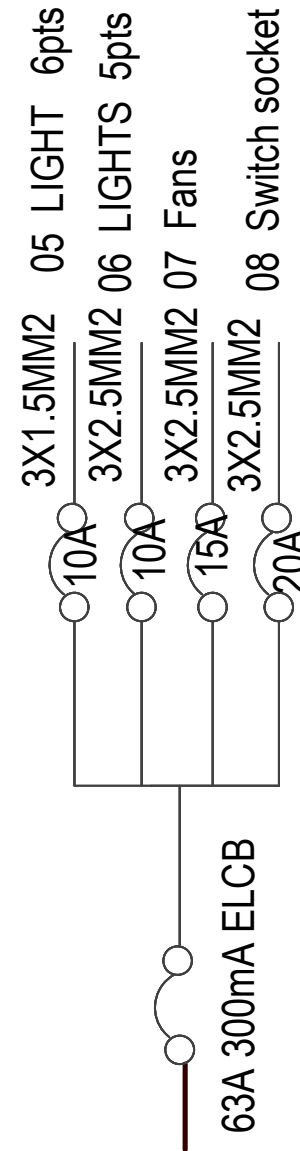

Building Section,
Policy Planning Department,
Ministry of Health, Community Development,
Gender, Elderly and Children.
University of Dodoma
College of Humanities and Social Science 11th
Building,
P.O.Box 743
40478 Dodoma

IN COLLABORATION WITH

President Office, Regional Administration and
Local Government
Mkapa Building,
P.O.Box 1923,
41185 Dodoma.

CLIENT

PRESIDENT'S OFFICE, REGIONAL ADMINISTRATION AND LOCAL
GOVERNMENT MKAPA BUILDING, P.O.BOX 1923, 41185 DODOMA.
PROJECT

**STANDARD DESIGN FOR COUNCIL LEVEL
HOSPITALS IN TANZANIA**

DRAWING TITLE

**SECURITY HOUSE
ELECTRICAL PLAN**

PROJECT NO.		SH /E101
DRAWN BY:	EEC	
CHECKED BY:	EEC	
DATE	MAY 2018	SCALE 1:100