


4WAYS SPN DISTRIBUTION BOARD INCINERATOR

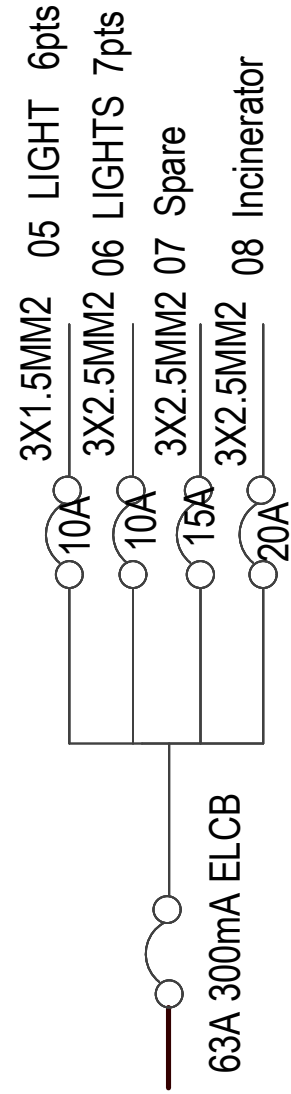

Building Section,
Policy Planning Department,
Ministry of Health, Community Development,
Gender, Elderly and Children,
University of Dodoma
College of Humanities and Social Science 11th
Building,
P.O.Box 743
40478 Dodoma

President Office, Regional Administration and
Local Government
Mkapa Building,
P.O.Box 1923,
41185 Dodoma.

IN COLLABORATION WITH

CLIENT
**PRESIDENT'S OFFICE, REGIONAL ADMINISTRATION AND LOCAL
GOVERNMENT MKAPA BUILDING, P.O.BOX 1923, 41185 DODOMA.**
PROJECT

**STANDARD DESIGN FOR COUNCIL LEVEL
HOSPITALS IN TANZANIA**

DRAWING TITLE		
INCINERATOR HOUSE		
ELECTRICAL PLAN		
PROJECT NO.		INC /E101
DRAWN BY:	EEC	
CHECKED BY:	EEC	
DATE	MAY,2018	SCALE 1:100