


8WAYS TPN DISTRIBUTION BOARD LAUNDRY

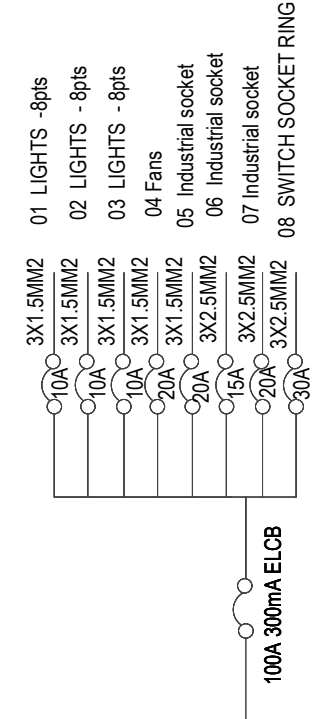

Building Section
 Planning and Policy Department
 Ministry of Health, Community Development,
 Gender Elderly and Children.
 University of Dodoma
 College of Humanities and Social Science 11th
 Building, P.O. Box 743,
 40478 Dodoma

In Collaboration with President's Office, Regional Administration
 and Local Government.
 Mkapa Building,
 P.O. Box 1923,
 41185 Dodoma

Client
 PRESIDENT'S OFFICE, REGIONAL ADMINISTRATION AND
 LOCAL GOVERNMENT, MKAPA BUILDING,
 P.O. BOX 1923, 41185 DODOMA

Project
 PROPOSED STANDARD DESIGN FOR COUNCIL LEVEL
 HOSPITALS IN TANZANIA

Drawing title		LN/DE/101
LAUNDRY ELECTRICAL PLAN		
Project number		Scale 1:150
Date	May, 2018	
Drawn by	EEC	
Checked by	EEC	