



DOOR & WINDOW SCHEDULE

NO.	WIDTH	HEIGHT	TOTAL
D1	3,000mm	3,000mm	1
W1	3,000mm	2,000mm	4

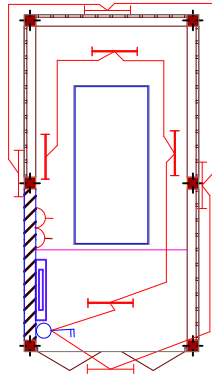

ELECTRICAL PLAN

TOTAL FLOOR AREA = 23.15 SQM

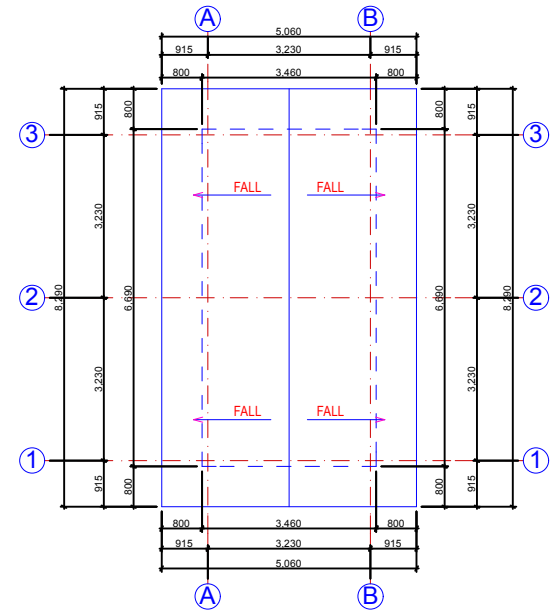

ROOF PLAN L[-]09

Building Section
 Planning and Policy Department
 Ministry of Health, Community Development,
 Gender Elderly and Children.
 University of Dodoma
 College of Humanities and Social Science 11th
 Building, P.O. Box 743,
 40478 Dodoma

In Collaboration with

President's Office, Regional Administration
 and Local Government.
 Mkapa Building,
 P.O. Box 1923,
 41185 Dodoma

Client

PRESIDENT'S OFFICE, REGIONAL ADMINISTRATION AND
 LOCAL GOVERNMENT, MKAPA BUILDING,
 P.O. BOX 1923, 41185 DODOMA

Project

STANDARD DESIGN FOR COUNCIL LEVEL HOSPITALS IN
 TANZANIA

Drawing title

POWER HOUSE BLOCK
 ELECTRICAL & ROOF PLAN

Project number

Date

May, 2018

Drawn by

EEC

Checked by

EEC

POW/E101

Scale 1:100